



10641 Highway 36  
Covington, GA  
30014

[www.sunbeltbuilders.com](http://www.sunbeltbuilders.com)


t 770.786.3031  
f 770.786.3046

## NEWTON COUNTY CENTRALIZED STORAGE FACILITY

Matt Davis Plumbing Company  
P.O. Box 230  
Covington, GA 30015  
ph: 678-625-1050  
Matt Davis  
[davisplumbingco@yahoo.com](mailto:davisplumbingco@yahoo.com)


22-0000 Plumbing As-built



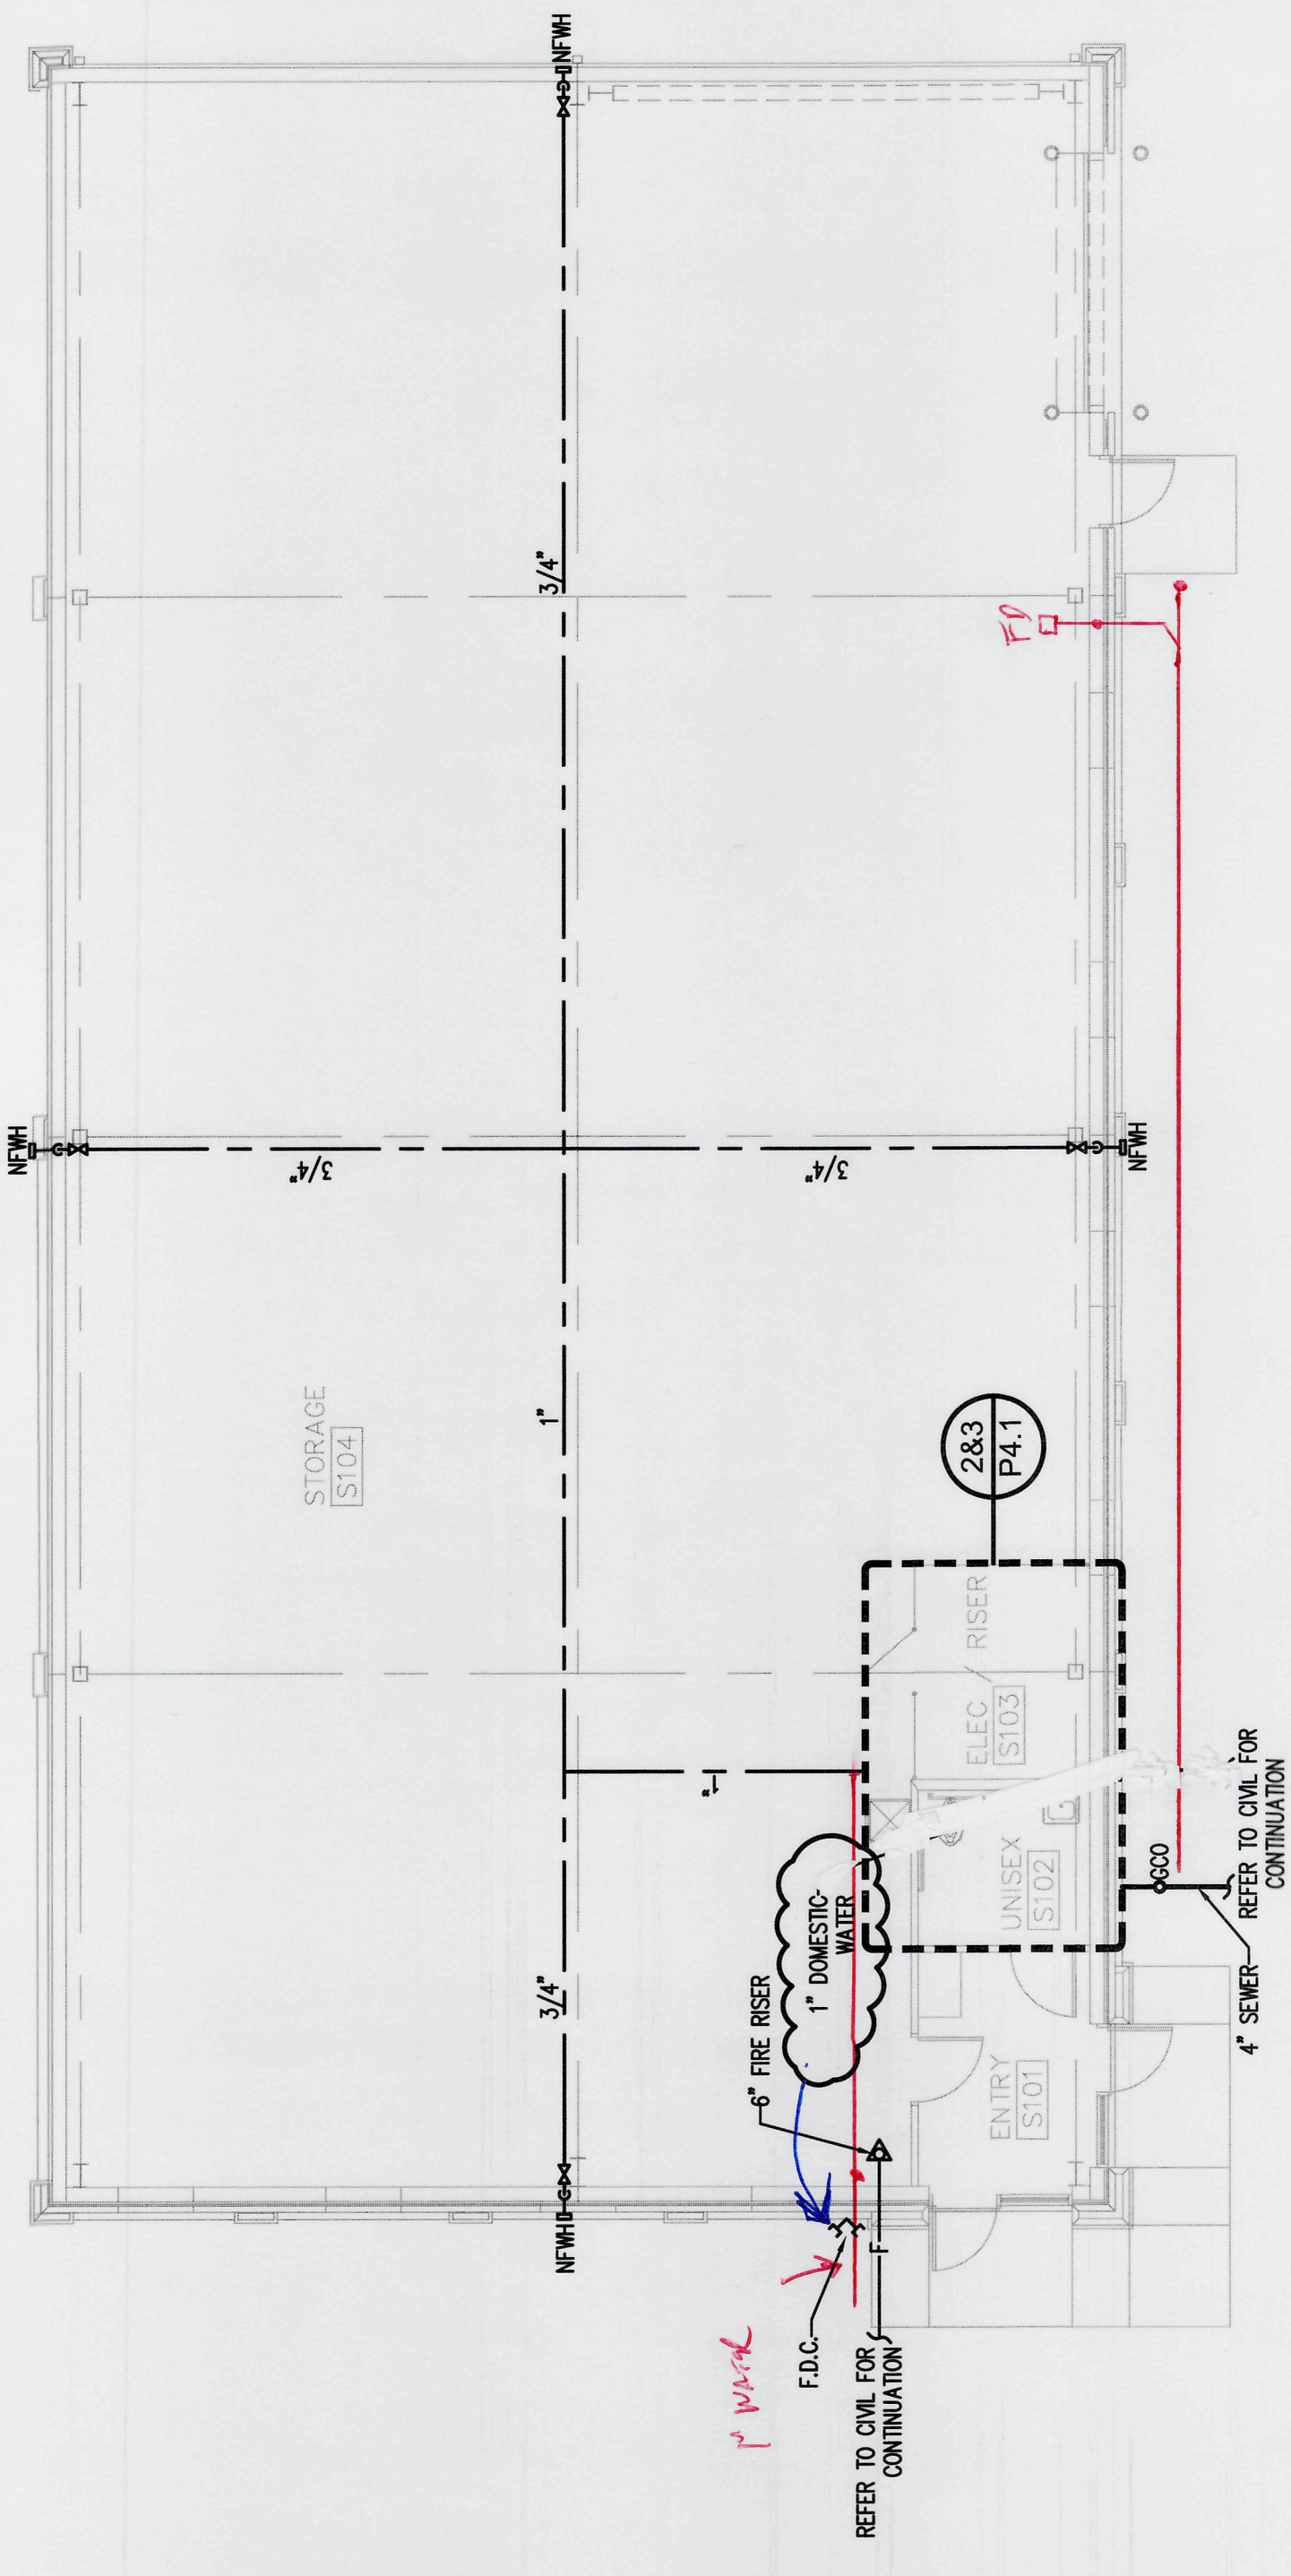


1 CENTRALIZE STORAGE FACILITY PLUMBING PLAN  
SCALE 1/4"=1'-0"

*As before*

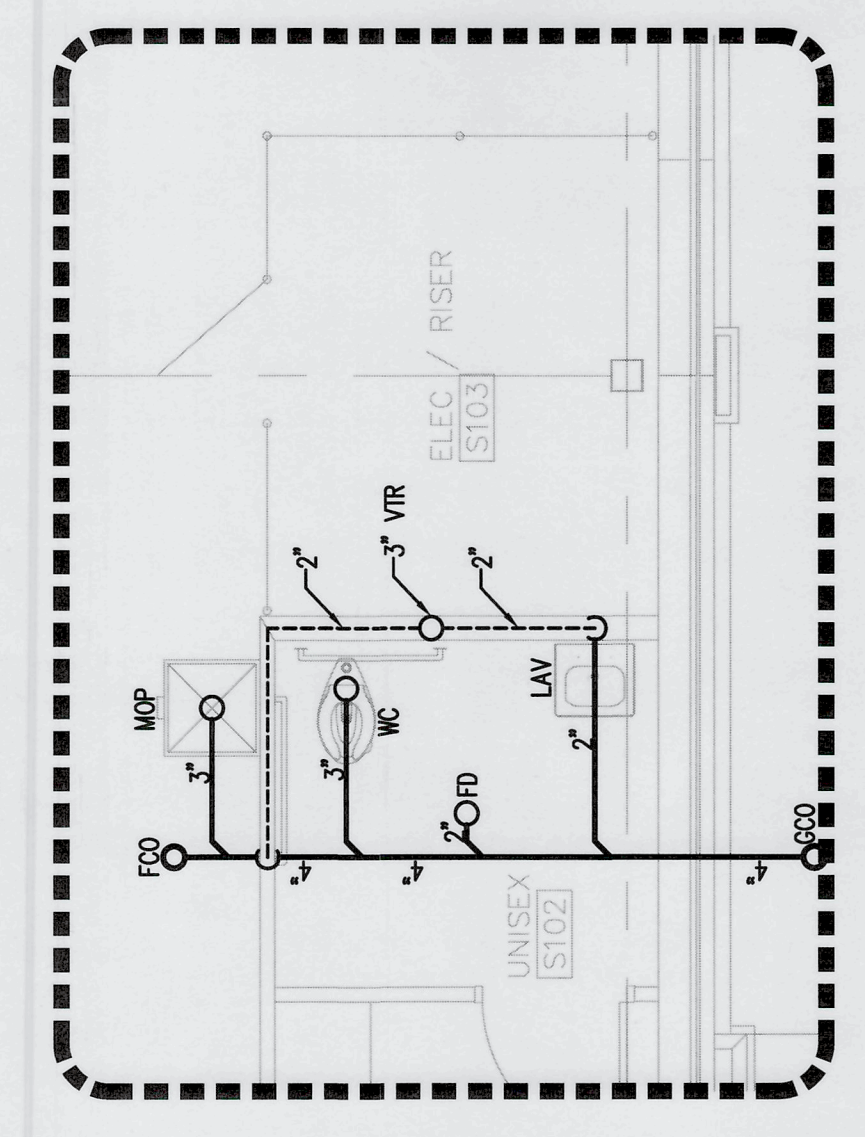

2 CENTRALIZE STORAGE FACILITY  
ENLARGED RESTROOM PLUMBING PLAN - SEWER  
SCALE 1/4"=1'-0"

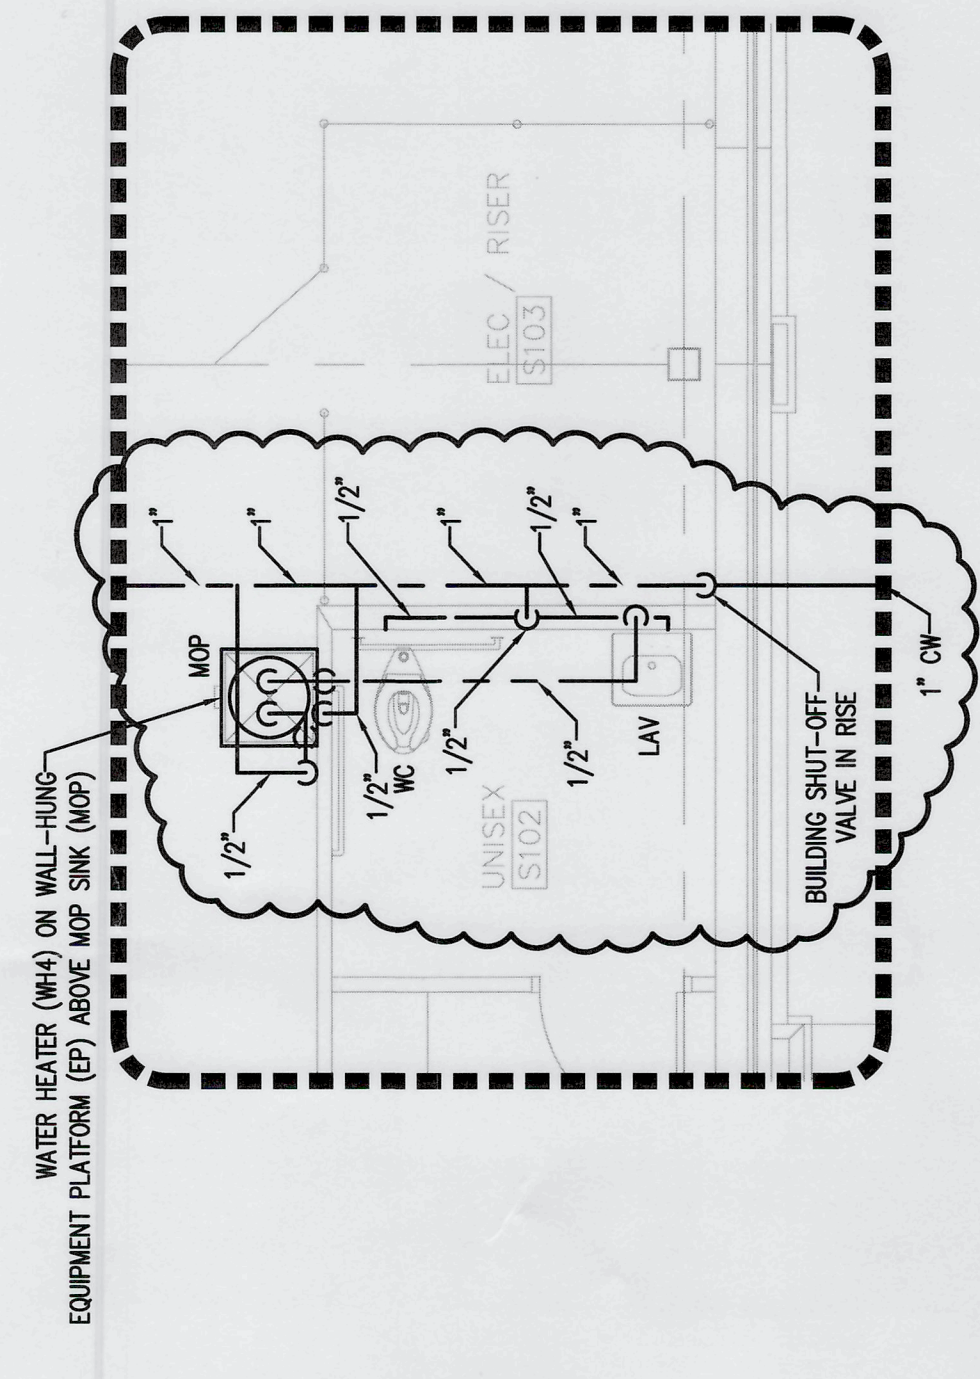

3 CENTRALIZE STORAGE FACILITY  
ENLARGED RESTROOM PLUMBING PLAN - WATER  
SCALE 1/4"=1'-0"

JOHN NO.:	03370
DRAWN BY:	JMK & KMP
CHECKED BY:	KMP
DESCRIPTION:	SCH-REVIEW
DATE:	02.27.24
DATE:	02.27.24
DATE:	00.00.24
DATE:	00.00.24
DESCRIPTION:	CD-REVIEW
DATE:	4.09.24
DESCRIPTION:	BD-CONSTRUCTION
DATE:	06.00.24
REVISIONS:	
1	00.00.24
2	05.24.24
3	07.09.24 VE
4	08.12.24
5	
6	
7	

THESE DRAWINGS ARE THE PROPERTY OF OWNER AND ARE NOT TO BE REPRODUCED OR COPIED WITHOUT PERMISSION OF THE ARCHITECT.  
COPYRIGHT: © 2024